



The name DUTCH BROS. and all associated signs, graphics, designs, and other materials required, displayed, contained herein, and made available by Dutch Bros., including but not limited to the "look and feel" of the establishment and products, all text, images, colors, configurations, graphics, designs, illustrations, photographs, and pictures (collectively, the "materials") are owned by and/or licensed by DB Franchising USA, LLC and are protected by copyright, trademark, trade dress, patent, and/or other intellectual property rights and unfair competition laws under the United States and foreign laws.

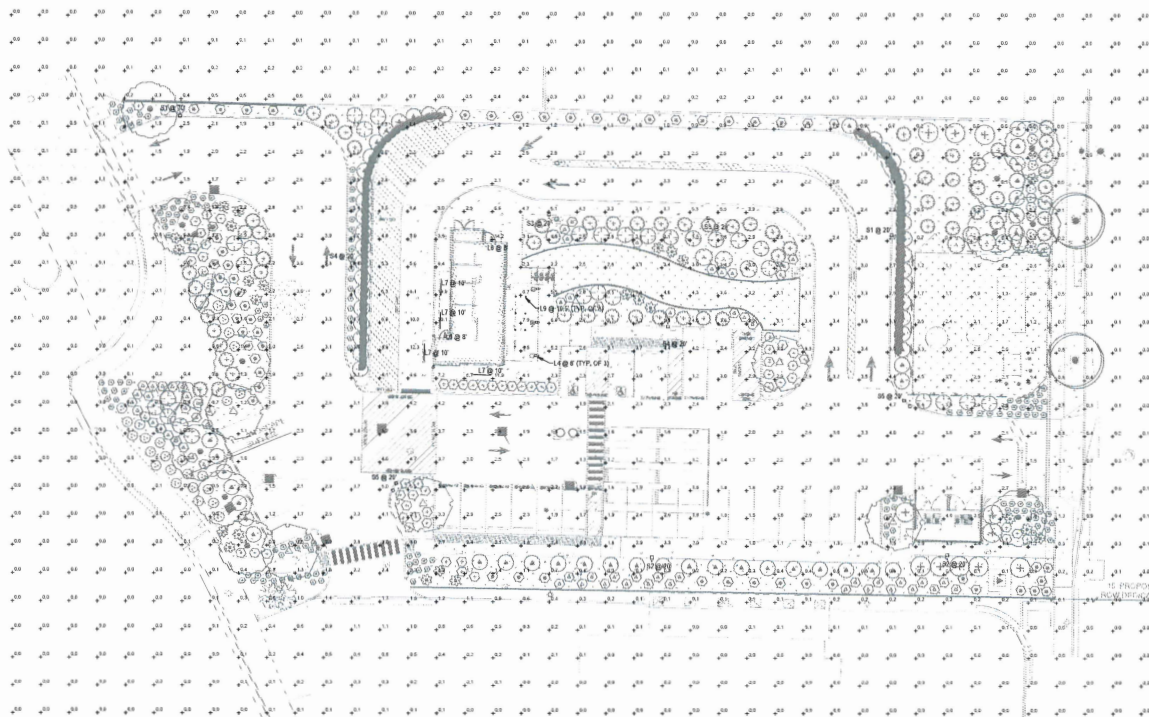

**1 ELECTRICAL PHOTOMETRIC PLAN**  
SCALE: 1" = 20'-0"

STATISTICS						
DESCRIPTION	SYMBOL	AVE.	MAX.	MIN.	MAX/MIN	AVE/MIN
DRIVE THRU	+	3.2%	12.3%	1.0%	12.3%	3.2%
DRIVEWAY	+	2.7%	3.0%	1.5%	4.5%	2.5%
GENERAL HARDSCAPE	+	2.6%	30.1%	0.5%	N/A	N/A
PARKING 1	+	2.2%	4.4%	2.3%	1.5%	1.5%
PARKING 2	+	2.2%	3.9%	1.5%	3.8%	1.5%
PARKING 3	+	1.5%	2.1%	1.0%	3.1%	1.5%
TRASH ENCLOSURE	+	3.8%	4.0%	3.5%	1.1%	1.1%

SCHEDULE							
SYMBOL	LABEL	QUANTITY	MANUFACTURER	CATALOG NUMBER (UNDER CANOPY OR BUG RATING)	DESCRIPTION	NUMBER OF LAMPS PER LAMP	WATTAGE
□	L4	3	LOOMAX	UMT-31416-02NA-1416W-H-WHS (UNDER CANOPY)	WATERTIGHT TWO SIDE SQUARE WALL LUMINAIRE	2	1100
□	L8	2	RAW LIGHTING INC.	WFL5000P-WFL5000P101 (WALL MOUNT)- ALUMINUM/BLACK/0.019 (AREA LIGHTING) (UNDER CANOPY)	CAST FIRMED METAL HOUSING MOLDED PLASTIC REFLECTOR WITH SEMI-SPHERICAL FINISH B1-H40-G1	1	3205
—	L7	4	SELF	CROWN-144-120V-B40-BAT10 (UNDER CANOPY)	CROWN-144-120V-B40-BAT10	1	4300
○	L9	6	DMF LIGHTING	DR255-4R-07930 (UNDER CANOPY)	DR255-4R-07930	1	757
□	S1	2	NLS LIGHTING LLC	NV-174-325-7-4064HSS (BUG RATING: BG-UG-G1)	NV SERIES AREA LIGHTING FIXTURE	1	5061
□	S2	2	NLS LIGHTING LLC	NV-173-325-7-4064HSS (BUG RATING: B1-UG-G2)	NV SERIES AREA LIGHTING FIXTURE	1	5004
□	S3	2	NLS LIGHTING LLC	NV-173-161-1-4064JNY (BUG RATING: B2-UG-G2)	NV SERIES AREA LIGHTING FIXTURE	1	6806
□	S4	2	NLS LIGHTING LLC	NV-173-325-1-40K (BUG RATING: B1-UG-G2)	NV SERIES AREA LIGHTING FIXTURE	1	13108
□	S5	2	NLS LIGHTING LLC	NV-173-325-1-40K (BUG RATING: B1-UG-G2)	NV SERIES AREA LIGHTING FIXTURE	1	13108

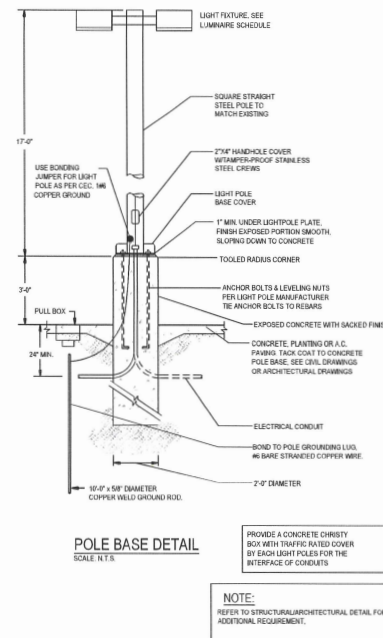

1300 OLIVE BLVD.  
SANTA MONICA, CALIFORNIA 90404  
PH 310 452-5531 FAX 310 455-4742

THE USE OF THESE PLANS AND SPECIFICATIONS SHALL BE LIMITED TO THE PROJECT AND SHALL NOT BE REPRODUCED OR TRANSMITTED IN ANY FORM OR BY ANY MEANS, ELECTRONIC OR MECHANICAL, INCLUDING PHOTOCOPYING, RECORDING, OR BY ANY INFORMATION STORAGE AND RETRIEVAL SYSTEM, WITHOUT THE WRITTEN PERMISSION OF THE ARCHITECT.

**ACIES**  
California  
402 N. Main Street, Suite 200  
San Francisco, CA 94104-3800  
Phone: 415.398.0000  
Fax: 415.398.0001



Project No: CA7301  
Dutch Bros Coffee - New Freestanding Store  
DB2550 - A1 PROTOTYPE  
13862 NORTH TUSTIN AVE.  
SANTA ANA, CA 92705

DATE: 02/26/2024  
REV. DATE: DESCRIPTION:

SHEET NO. 141

PHOTOMETRIC SITE PLAN


SHEET NUMBER:  
E0.02

© 2019 DB Franchising USA, LLC










**L7**

**Job: Dutch Brothers Coffee**  
**Descr: Canopy @ light**


## Outdoor Cove Lighting

### CROWN


**166**




- Serial: 100100100
- Channel: 1/2" commercial 60% 600S
- Voltage: 120V commercial 72" x 200AC, 1NF 4077-10C
- 3-Phase 120V 3-Phase 100Watt
- Includes anti-rainproof hardware
- 100% IP65 protection
- Voltage: 300VAC 120V 20A
- 100% IP65 protection
- Includes anti-rainproof
- Voltage: 100Watt




**NOTE**




**Dimensions: (inches/mm)**






**Wiring Diagram**

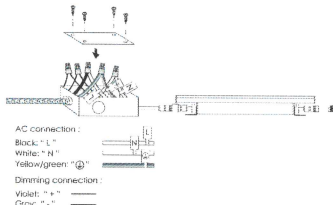

The diagram shows the internal wiring of the fixture. It includes a terminal block with the following connections:

- AC connection:**
  - Black: "L"
  - White: "N"
  - Yellow/Green: "G"
- Dimming connection:**
  - Violet: "+"
  - Gray: "-"

The diagram also shows the connection of the fixture to the power source and the dimmer switch.

63 •  • www.spf-electronics.com

**Outdoor Cove Lighting**  
CROWN

How to order using our catalog numbers:  
Example: 000000 000000 000000

Series	Length	Color Temp	Beam Angle	Finish	Installation
CROWN	12" x 1.8" (20Ground) 12" x 4" (120Ground) 10" x 9" (77Ground)	800K - 9000K 800K - 9000K	110° - 120°	5 - 12mm	5 - 12mm Max End

Catalog No.	Model	Description				Installed
		Actual Input	Ra	Wattage	Conversion Eff. (Typical)	
CR09W-0200-1005	CR09W-034-077P	100-277VAC	85	100W	1030 lm	Type: 0-6-6-6-6-6 Size: 6-6-6-6-6-6 Spec: 6-6-6-6-6-6
CR09W-0400-1005		100-277VAC	85	40W	630 lm	
CR09W-0700-1005		100-277VAC	85	40W	630 lm	
CR09W-0700-1005		100-277VAC	85	40W	630 lm	
CR09W-0700-1005	CR09W-034-077P	100-277VAC	85	40W	630 lm	

How to choose your driver & cables:



Catalog No.	Description	Photo
IC-CZ0W6-01	Input cable 6P	

Optional:

Catalog No.	Description	Photo
20-CROWN-12	Left connector 12"	
16-CROWN-75	Right RF, including 3/4 x 2 x 25	

### Outdoor Cove Lighting

**Installation** [Download](#) [Help](#) [Feedback](#)

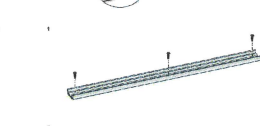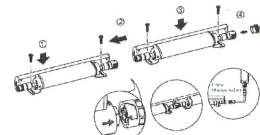

ARMET DAVIS NEWLOVE &  
ASSOCIATES, AIA ARCHITECT

1330 OLYMPIC BLVD.  
SANTA MONICA, CALIFORNIA 90404  
PH 310 452-5525 FAX 310 450-4742

THE USE OF THESE PLANS AND SPECIFICATIONS SHALL BE RESTRICTED TO THE ORIGINAL SITE FOR WHICH THEY WERE PREPARED AND PUBLICATION THEREOF IS EXPRESSLY LIMITED TO SUCH USE. RE-USE, REPRODUCTION OR PUBLICATION BY ANY METHOD, IN WHOLE OR IN PART, IS PROHIBITED. AS TO THE PLANS AND SPECIFICATIONS REGARDING THE ARCHITECT WITHOUT PREJUDICE, VISUAL CONTACT WITH THE PLANS AND SPECIFICATIONS SHALL CONSTITUTE FRAUD. EVIDENCE OF THE ACCEPTANCE OF THE RESTRICTIONS.

**ACIES**  
ENGINEERING  
400 N. McCarthy Blvd., Suite 250  
Milpitas CA 95035  
ph (408)522-5255 | fx (408)522-5260  
info@acies.net | Copyright © 2003



Project No: CA7301  
Dutch Bros Coffee - New Freestanding Store  
DB2550 - A1 PROTOTYPE  
13862 NORTH TUSTIN AVE.  
SANTA ANA, CA 92705

DATE 02/26/2024

REV	DATE	DESCRIPTION
-----	------	-------------

SHEET NAME:

EXTERIOR LIGHTING  
CUTSHEETS

SHEET NUMBER:

E0.05